




平面図

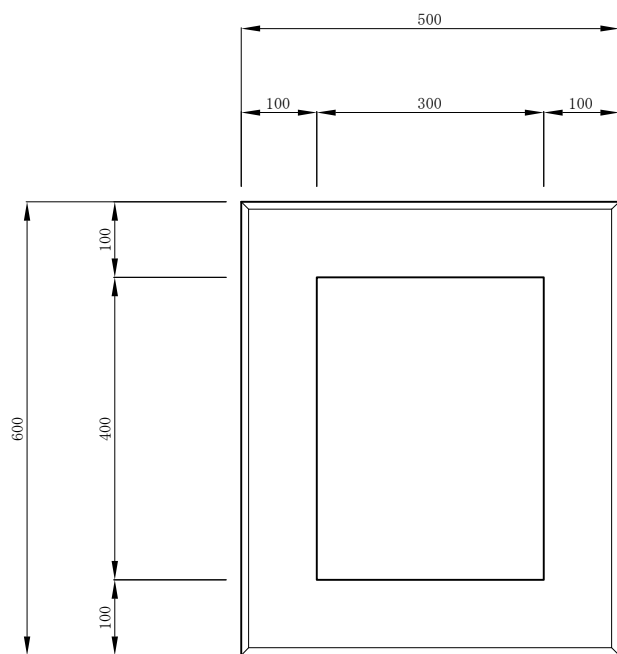

側面図

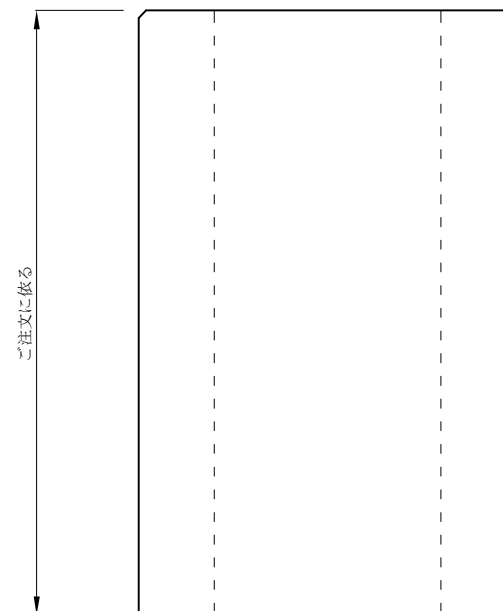

呼び名	L形集水桝 300用		
寸法	300/500×400/600		
縮尺	S=1:10	単位	mm
 ヤマケイプレコン株式会社			